


MAG DESIGNS
 982 MAIN STREET, SUITE 4-116
 FISHKILL, N.Y. 12524
 P. (845) 440-3384 F. (845) 440-3359

I am a holder of the law for my partner, unless and only under the direction of a licensed professional, do not call him in any way. For him holding the seal of a licensed professional is illegal. The design of the professional is not to be used in any way without the written consent of the holder of the seal and the seal of the holder of the seal.



Village Pancake Factory
 1099 Route 9
 Fishkill, NY 12524
 PHOTOMETRIC OF NEW LIGHT POLE FIXTURES

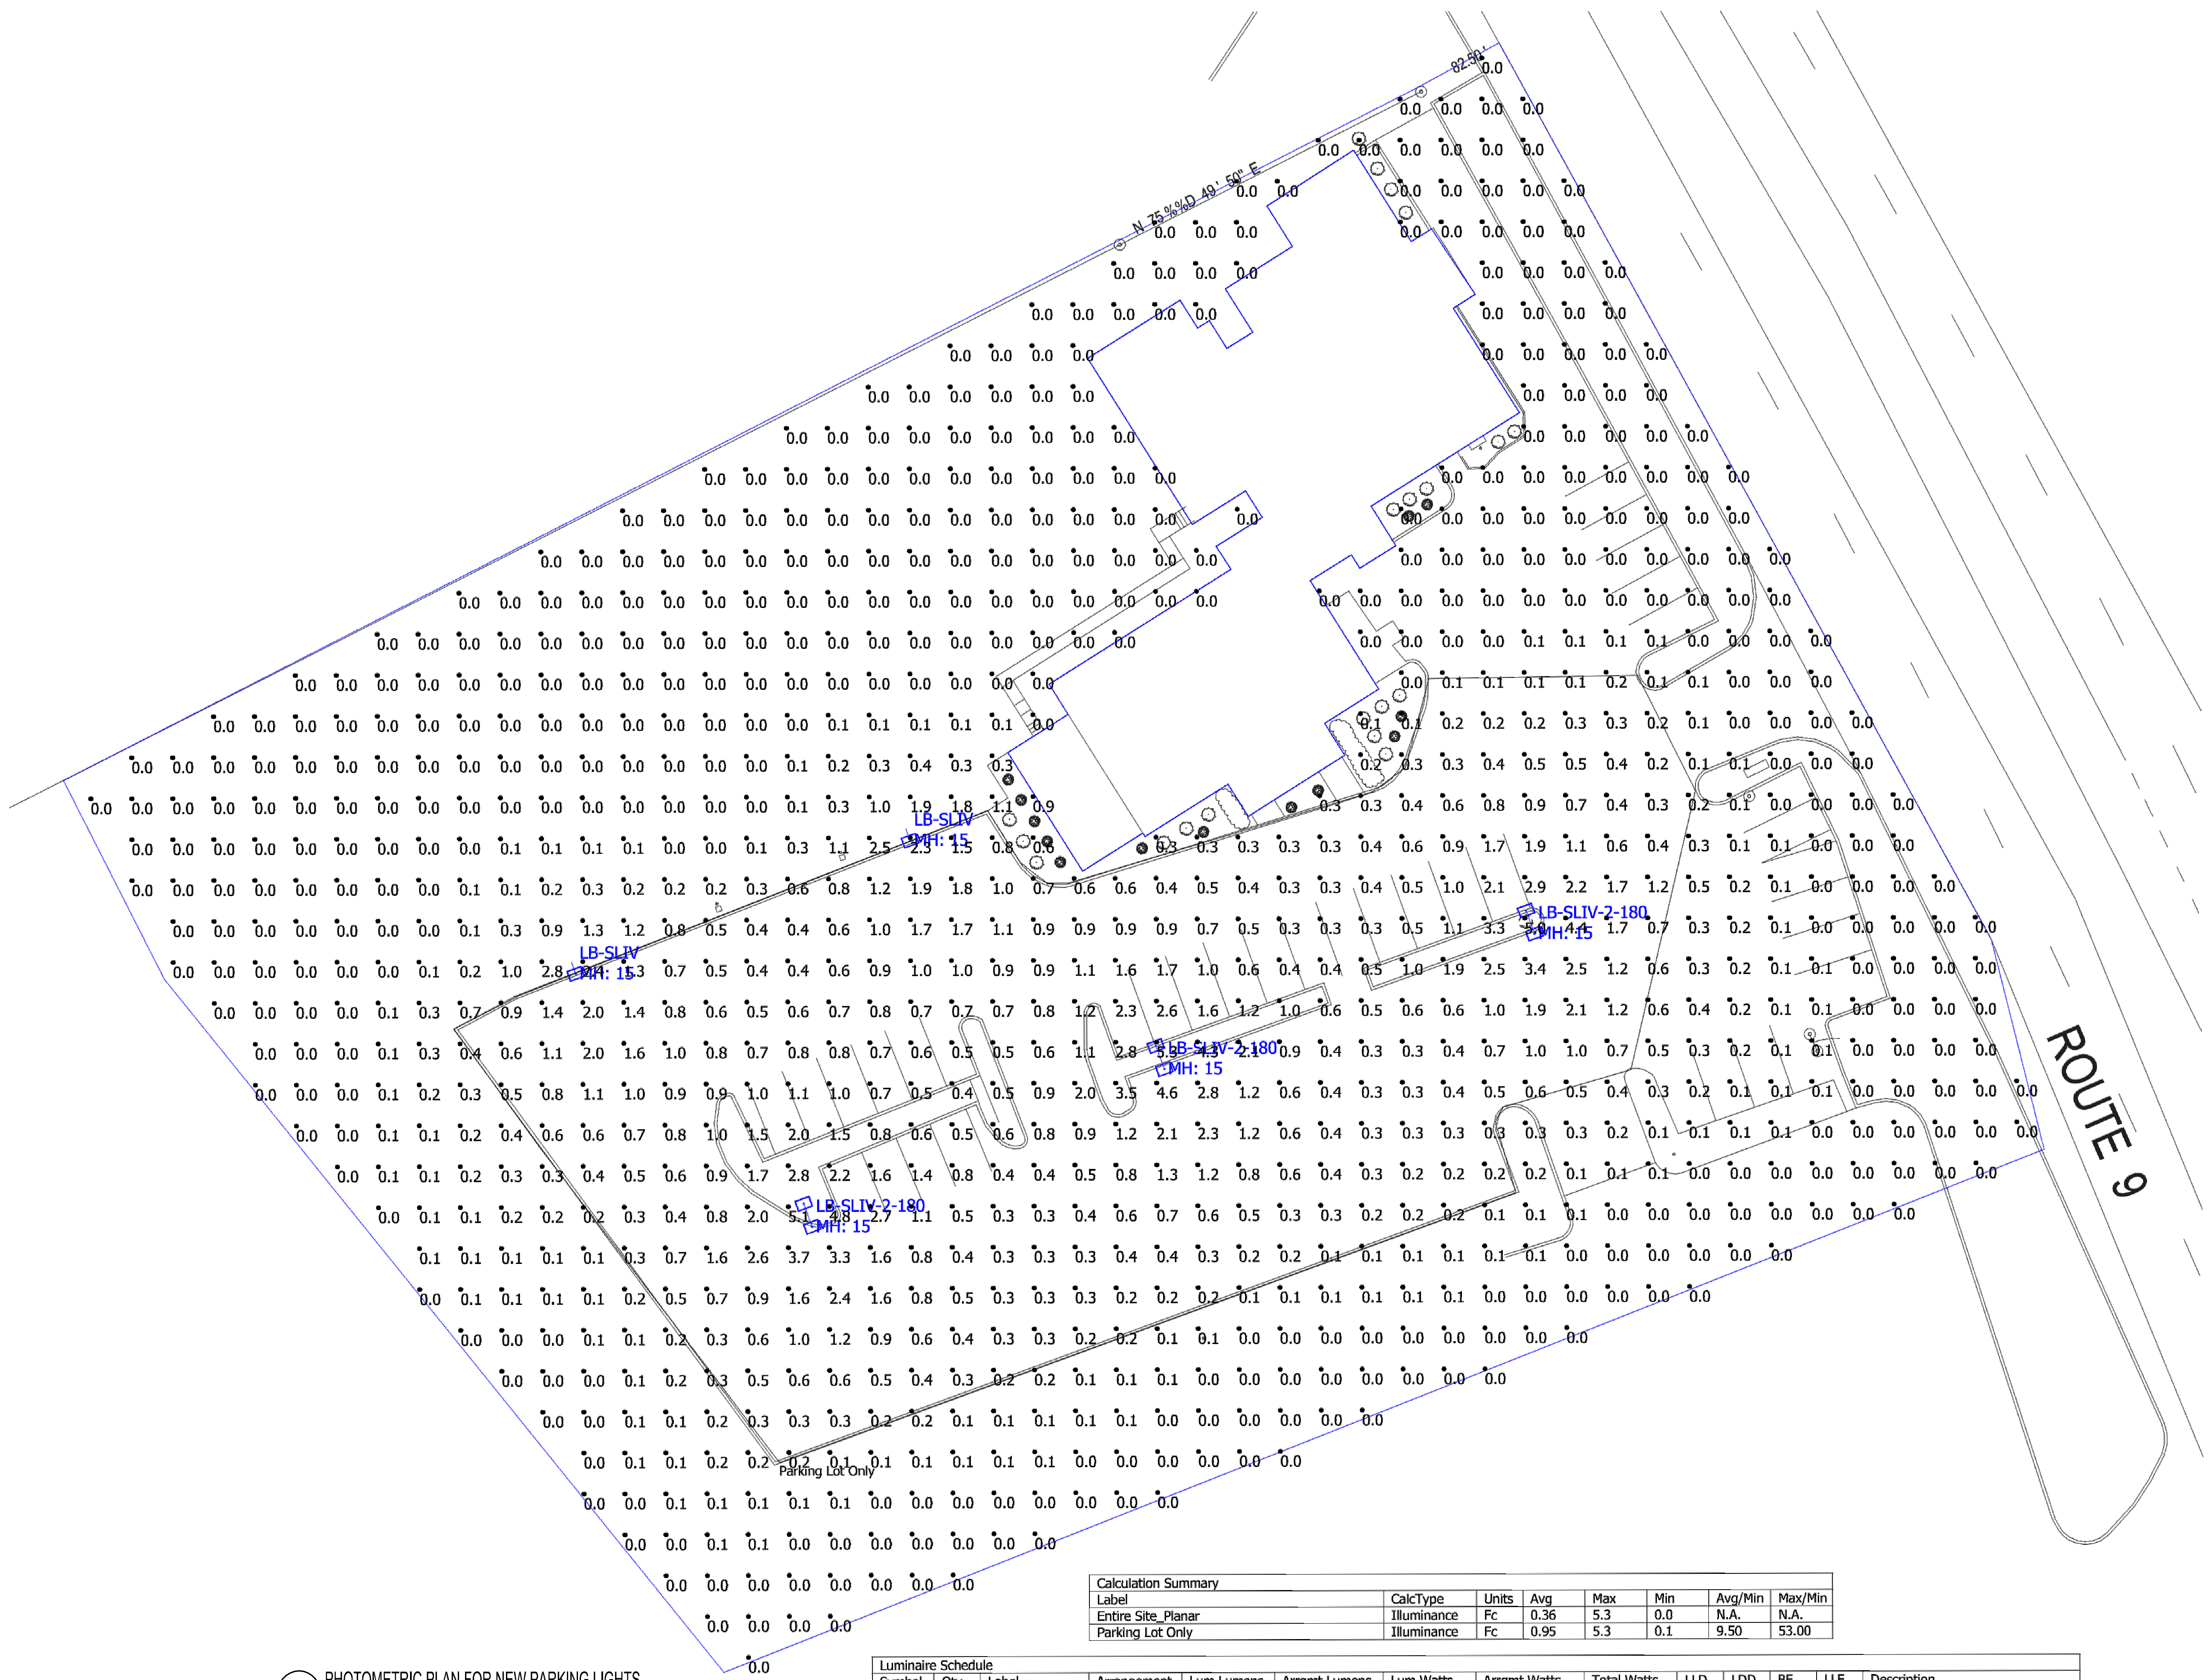

Label	CalcType	Units	Avg	Max	Min	Avg/Min	Max/Min
Entire Site Planar	Illuminance	Fc	0.36	5.3	0.0	N.A.	N.A.
Parking Lot Only	Illuminance	Fc	0.95	5.3	0.1	9.50	53.00

Symbol	Qty	Label	Arrangement	Lum Lumens	Arrgmt Lumens	Lum Watts	Arrgmt Watts	Total Watts	LLD	LDD	BF	LI	LIIF	Description
[Symbol]	3	LB-SLIV-2-180	Back-Back	5017	10034	39.8	79.6	238.8	0.950	0.950	1.000	0.903	0.903	GALN-SB1B-830-U-SL4
[Symbol]	2	LB-SLIV	Single	5017	5017	39.8	39.8	79.6	0.950	0.950	1.000	0.903	0.903	GALN-SB1B-830-U-SL4

1 PHOTOMETRIC PLAN FOR NEW PARKING LIGHTS
 SCALE: 1"=20'-0"

REVISIONS

COPYRIGHT:
MAG Design Architectural Services, Inc. reserves the copyright and other proprietary rights in this document. These documents shall be reproduced in any form or manner, not in whole or in part, without the written consent of MAG Design Architectural Services, Inc. All rights reserved. No part of this document may be reproduced in any form or manner without the prior written permission of MAG Design Architectural Services, Inc. All rights reserved. No part of this document may be reproduced in any form or manner without the prior written permission of MAG Design Architectural Services, Inc. All rights reserved. No part of this document may be reproduced in any form or manner without the prior written permission of MAG Design Architectural Services, Inc. All rights reserved.

File:
 Date: 6/12/25 Job: 2501
 Scale: 1" = 20'-0"

Main
A009